


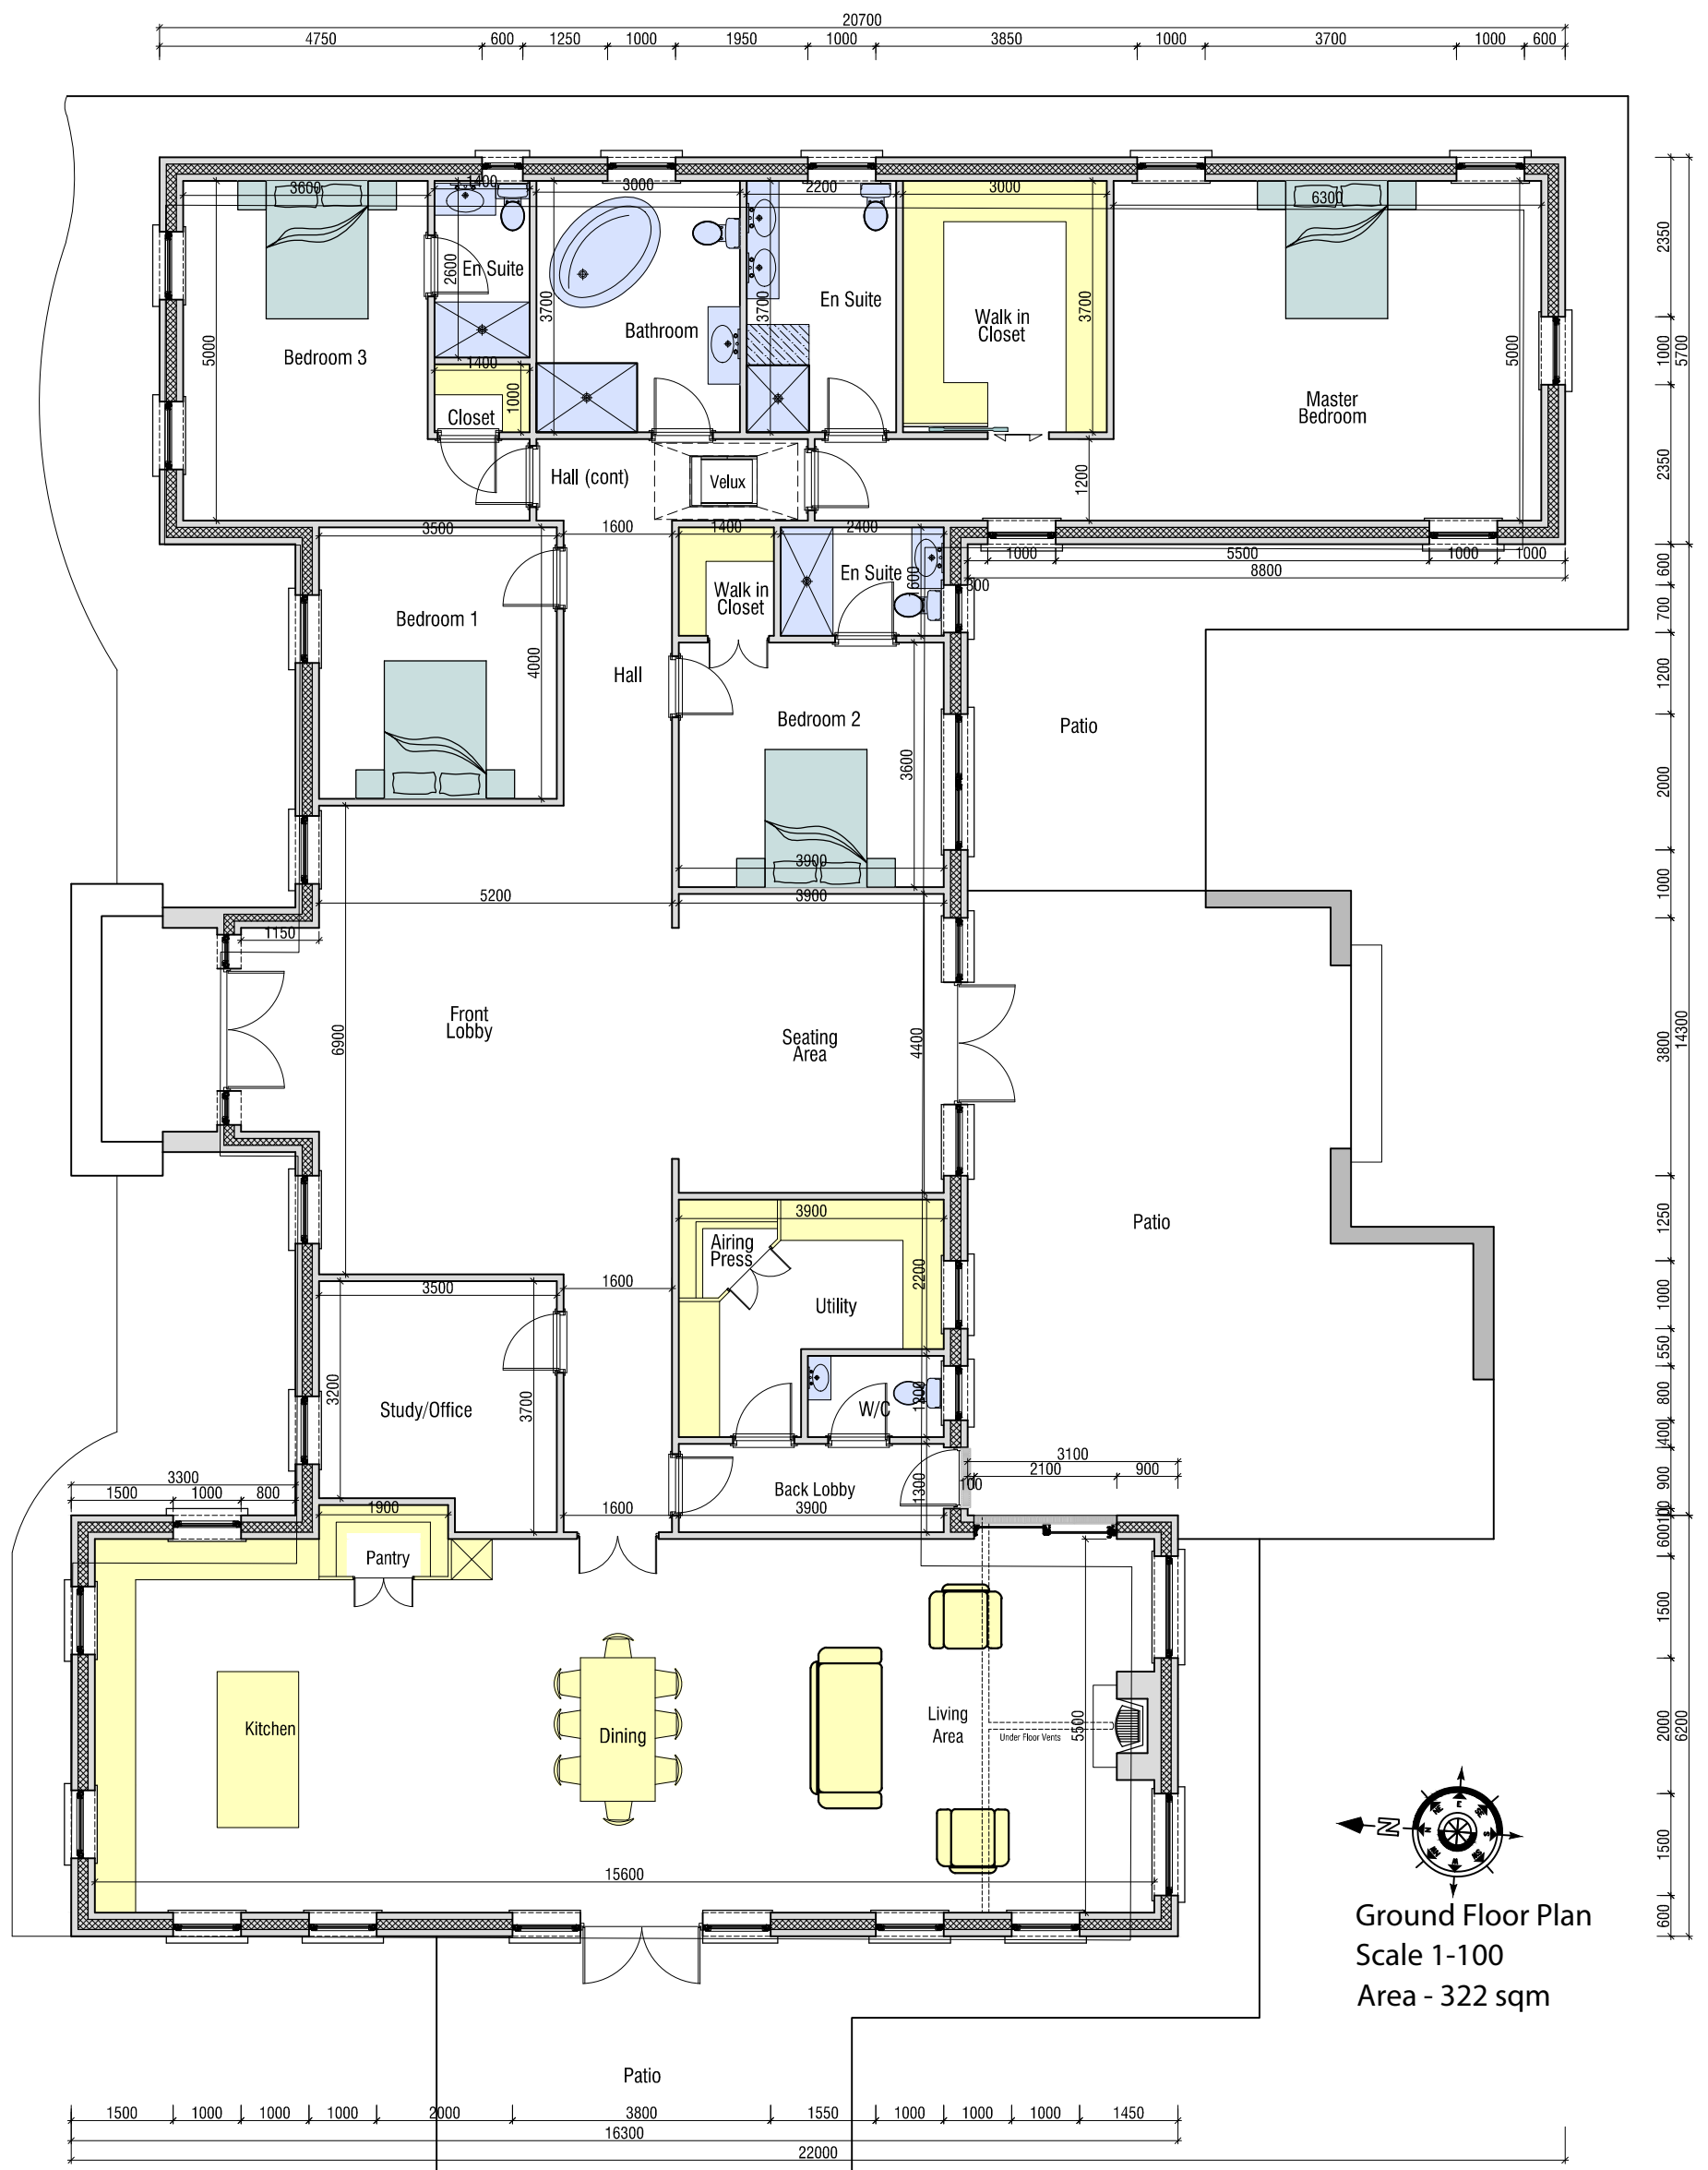

LESLIE COLTON

Dip.Str.Eng.Tech

Mobile: 086-8188472
Tel: 05786-25448
E-Mail: leslicoltonlaois@gmail.com

**ENGINEERING
AND
ARCHITECTURAL
SERVICES**

Applicant: John Egan & Ciara Finlay

Job: Dwelling House, Domestic Garage, Septic Tank, Percolation Area & Associated Works

Location:

Drawing: Floor Plan of Proposed Dwelling

Dwg No.: 19-22

Sheet No.: 01

Scale: 1/100

Area: 322 sqm

Date: 07-06-2022